



**1 ENLARGED PIPING FLOOR PLAN - DEMO**  
1/4" = 1'-0"

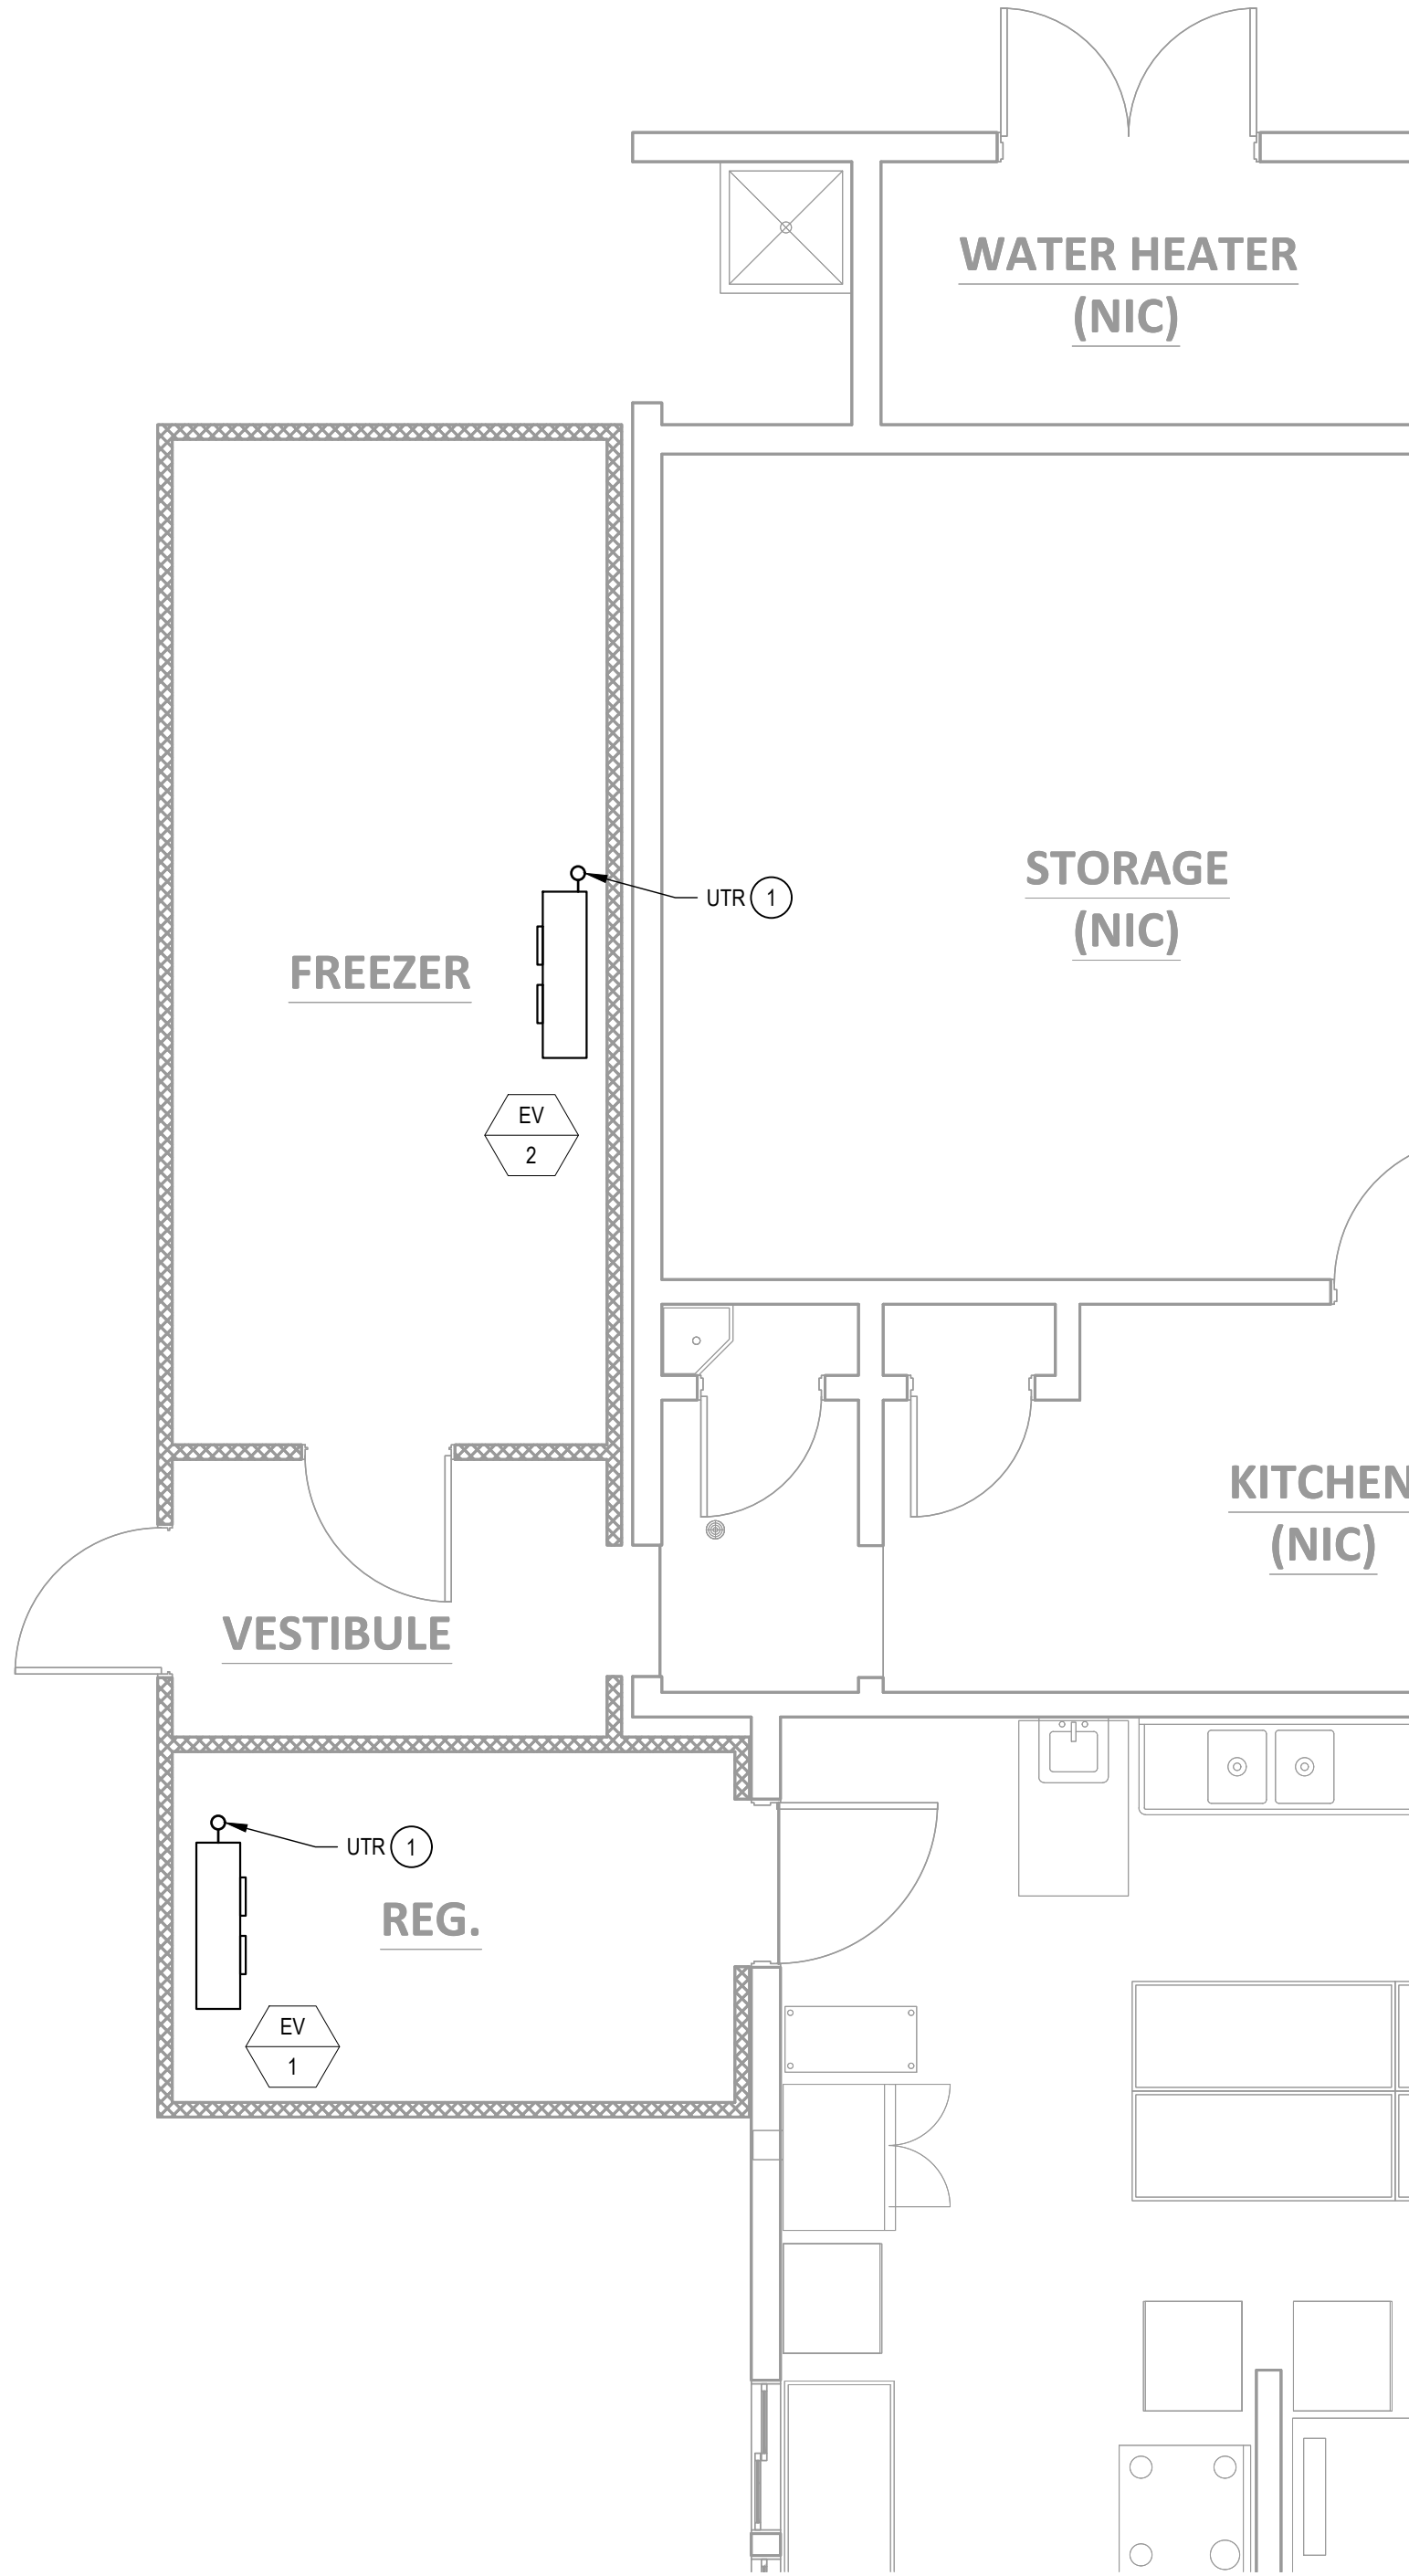

**2 ENLARGED PIPING FLOOR PLAN - NEW**  
1/4" = 1'-0"

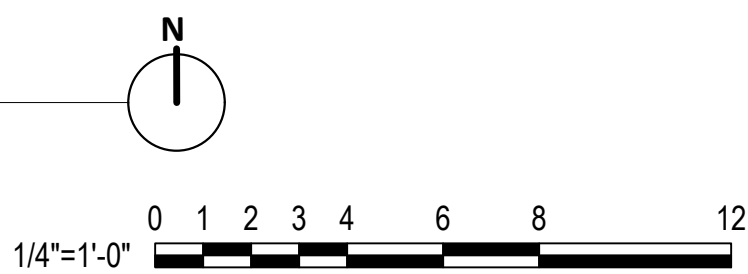

**DEMOLITON GENERAL NOTES**

1. EQUIPMENT AND REFRIGERANT LINESETS ARE APPROXIMATE.

**DEMOLITION KEYNOTES**

- 1** DEMO EXISTING COLD BOXES, REFRIGERANT LINESETS, EVAPORATORS AND CONDENSERS ON ROOF.

**GENERAL NOTES**

1. INSULATE REFRIGERANT SUCTION LINE. PROVIDE ALUMINUM JACKETING OVER REFRIGERANT PIPING INSULATION.

**KEYNOTES**

- 1** REFRIGERANT LINESET ROUTED FROM WALK-IN COOLER EVAPORATOR TO OUTDOOR CONDENSING UNIT.

ENLARGED FLOOR PLANS PIPING - DEMO & NEW

SAN DIEGO UNIFIED SCHOOL DISTRICT  
KITCHEN MODIFICATIONS GROUP 6  
**BELL MIDDLE SCHOOL**  
620 BRIARWOOD RD.  
SAN DIEGO, CA 92139  
BID SET

PROJECT NO. SDUF-002

DATE 04/12/25




REVISIONS

SHEET NO.

**M4.0**

PREPARED FOR THE  
**BOARD OF EDUCATION**

PREPARED BY THE  
**obr/ARCHITECTURE**  
2419 EL CAJON BLVD, SAN DIEGO, CA 92104

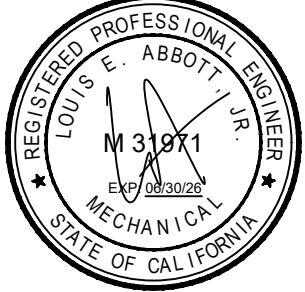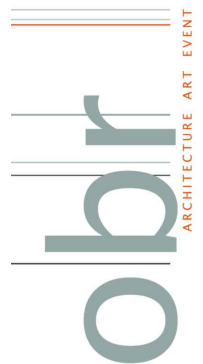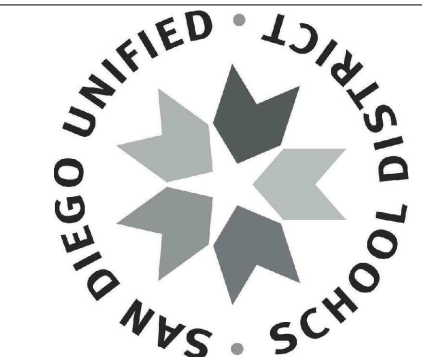

FOR DSA REVIEW ONLY -  
NOT FOR CONSTRUCTION

